


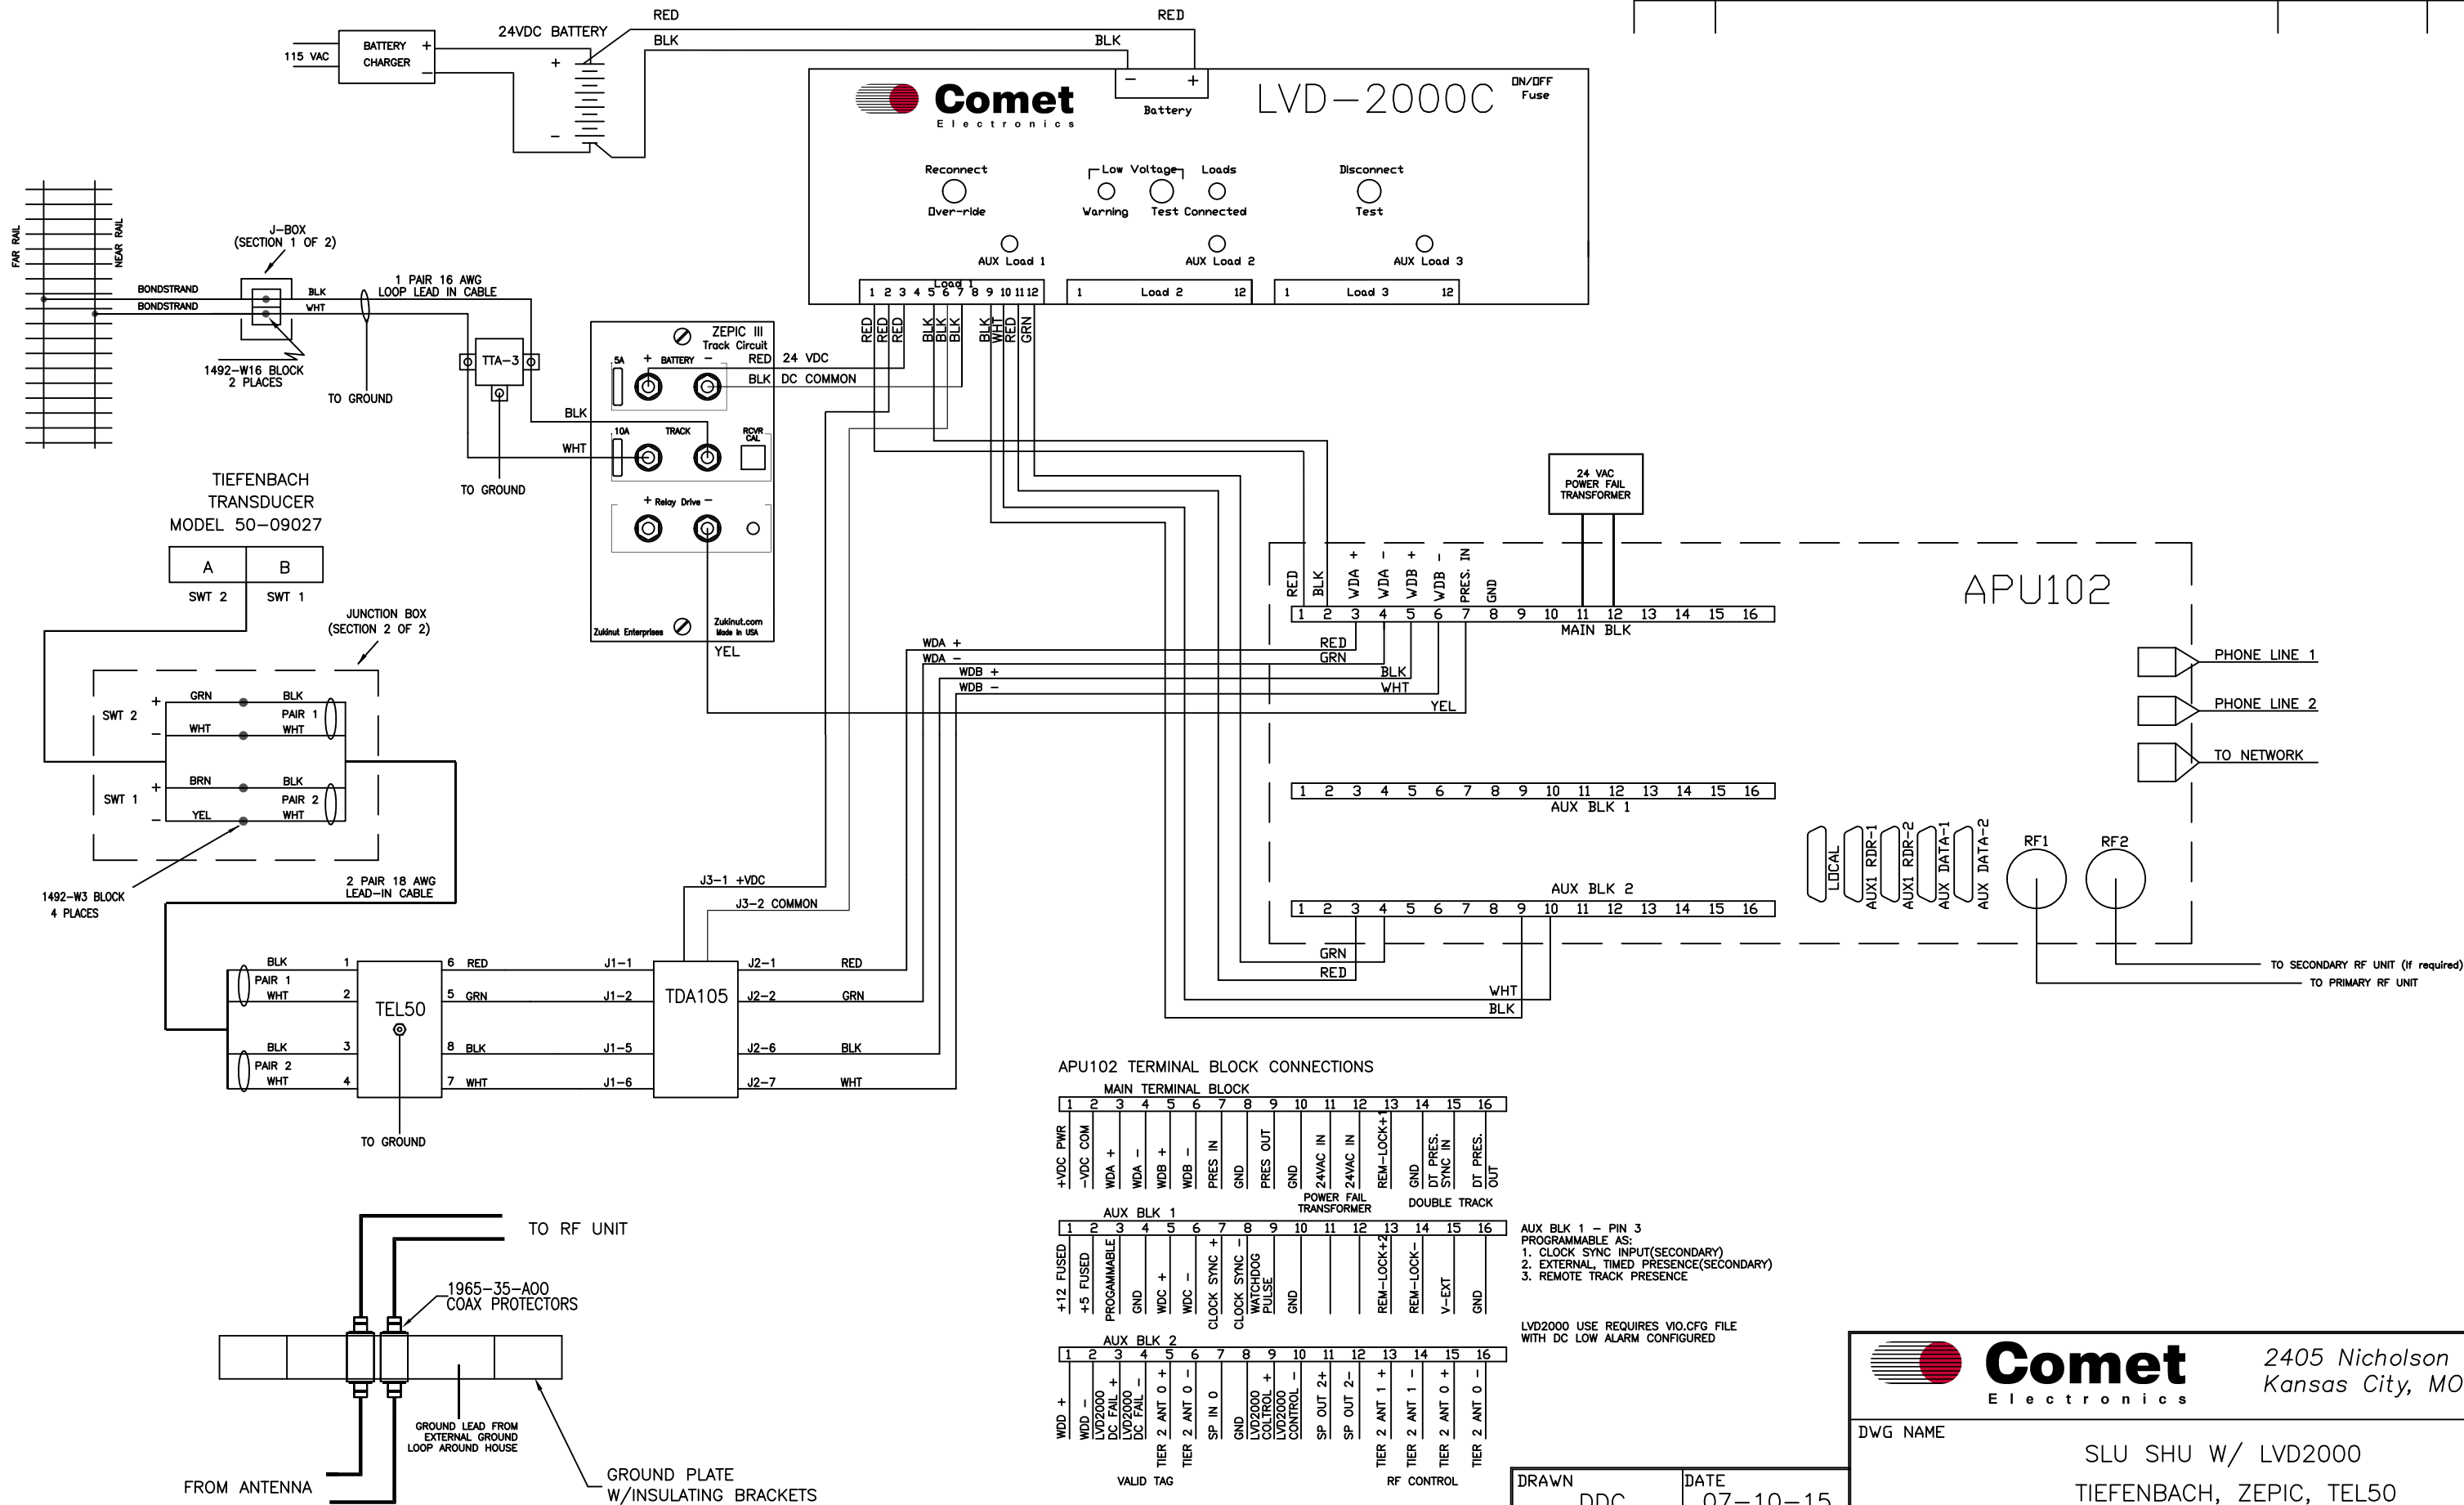

APU102 TERMINAL BLOCK CONNECTIONS

MAIN TERMINAL BLOCK															
1	2	3	4	5	6	7	8	9	10	11	12	13	14	15	16
+VDC PWR	-VDC COM	WDA +	WDA -	WDB +	WDB -	PRES IN	GND	PRES OUT	GND	24VAC IN	24VAC IN	REM-LOCK+	GND	DT PRES. SYNC IN	DT PRES. OUT
POWER FAIL TRANSFORMER															
1	2	3	4	5	6	7	8	9	10	11	12	13	14	15	16
+12 FUSED	+5 FUSED	PROGRAMMABLE	GND	WDC +	WDC -	CLOCK SYNC +	CLOCK SYNC -	WATCHDOG PULSE	GND	REM-LOCK+	REM-LOCK+	REM-LOCK+	REM-LOCK+	V-EXT	GND
DOUBLE TRACK															
1	2	3	4	5	6	7	8	9	10	11	12	13	14	15	16
WDD +	WDD -	LVD2000 DC FAIL +	LVD2000 DC FAIL -	TIER 2 ANT 0 +	TIER 2 ANT 0 -	SP IN 0	GND	LVD2000 COLTRIL +	LVD2000 COLTRIL -	SP OUT 2+	SP OUT 2-	TIER 2 ANT 1 +	TIER 2 ANT 1 -	TIER 2 ANT 0 +	TIER 2 ANT 0 -
VALID TAG															
RF CONTROL															

AUX BLK 1 - PIN 3
PROGRAMMABLE AS:
1. CLOCK SYNC INPUT(SECONDARY)
2. EXTERNAL TIMED PRESENCE(SECONDARY)
3. REMOTE TRACK PRESENCE

LVD2000 USE REQUIRES VIO.CFG FILE
WITH DC LOW ALARM CONFIGURED

DRAWN DDC	DATE 07-10-15
ENGINEER DDC	DATE
APPROVED	DATE

		2405 Nicholson Ave. Kansas City, MO 64120	
DWG NAME SLU SHU W/ LVD2000 TIEFENBACH, ZEPIC, TEL50			
COMET Proprietary USE OF THIS DOCUMENT AND INFORMATION IS ONLY GRANTED UNDER CONSIDERATION OF OR USE UNDER CONTRACTUAL AGREEMENT. DOCUMENT IS PROPERTY OF COMET AND MUST BE RETURNED/DESTROYED ON REQUEST.		DWG NO. 70-0274-01	PARTS SHOWN REV -
DIMENSIONS: IN [mm]	SCALE N.T.S.	SHEET 1	OF 1

EXPORT REQUIREMENT NOTICE:
THESE COMMODITIES, TECHNOLOGY OR SOFTWARE WERE EXPORTED FROM THE UNITED STATES
IN ACCORDANCE WITH THE EXPORT ADMINISTRATION REGULATIONS. DIVERSION CONTRARY TO
U.S. LAW IS PROHIBITED. THE COMMODITIES MAY NOT BE RESOLD, TRANSFERRED, TRANSSHIPPED
OR REEXPORTED WITHOUT PRIOR AUTHORIZATION BY THE U.S. GOVERNMENT.