
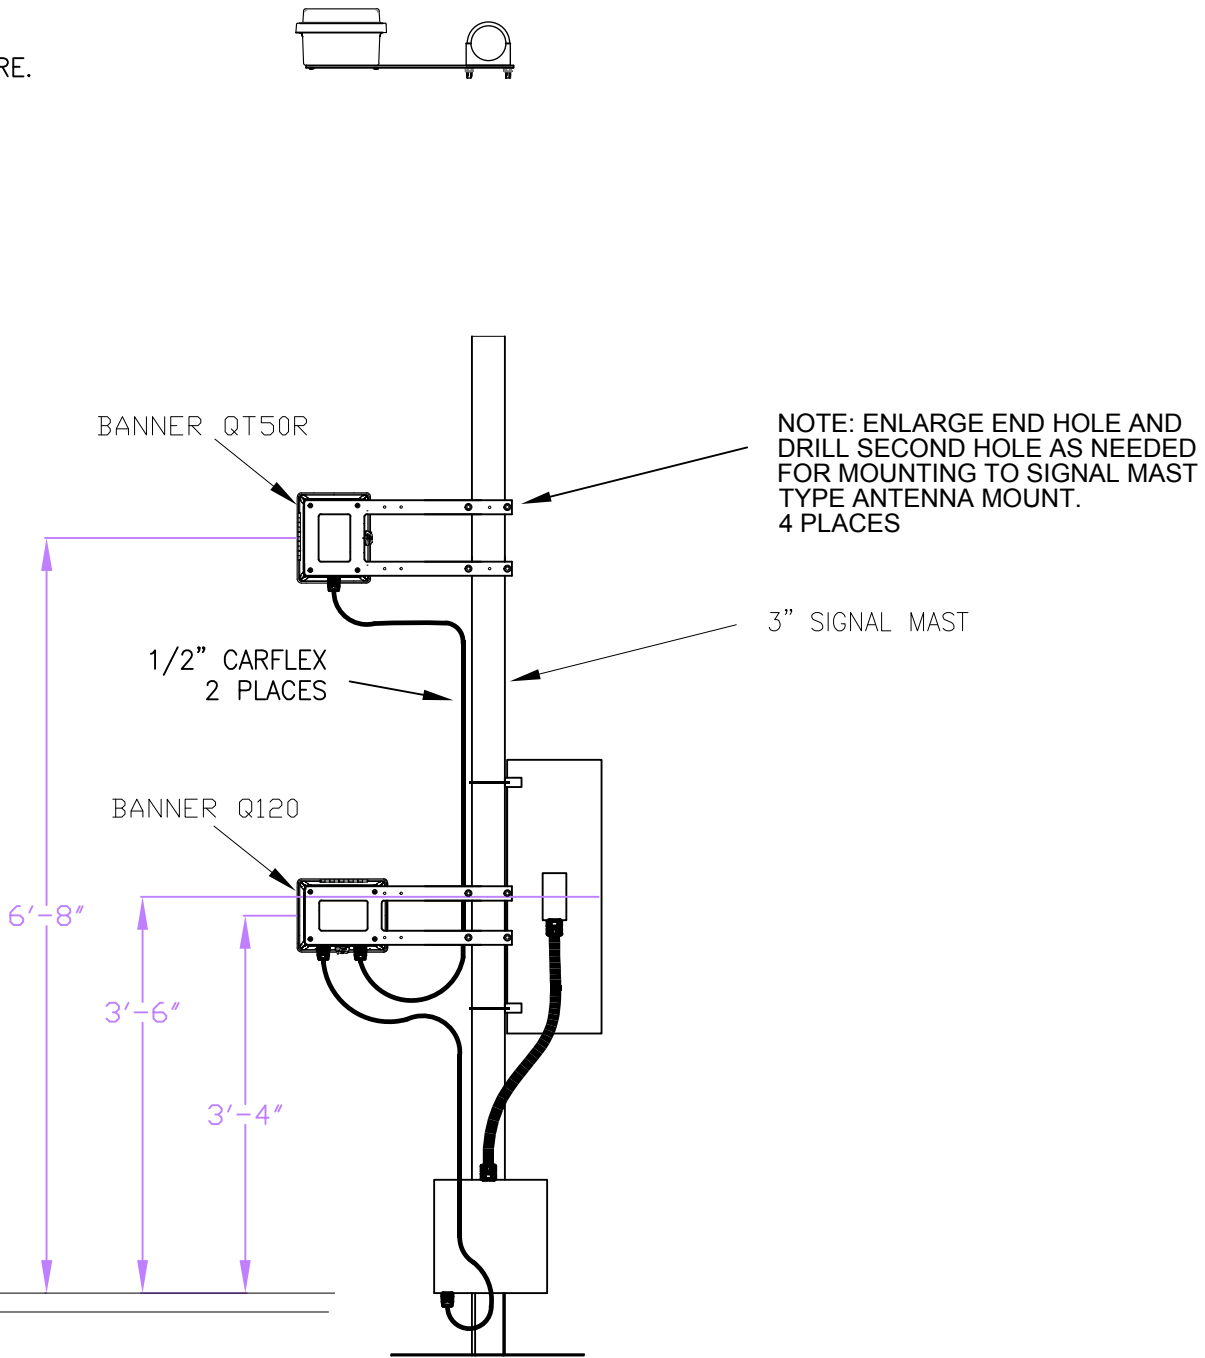


REV	REVISION DESCRIPTION	DATE	APPROVAL
A	ADDED DETAIL FOR SIGNAL TYPE ANTENNA MAST	03.21.18	DDC

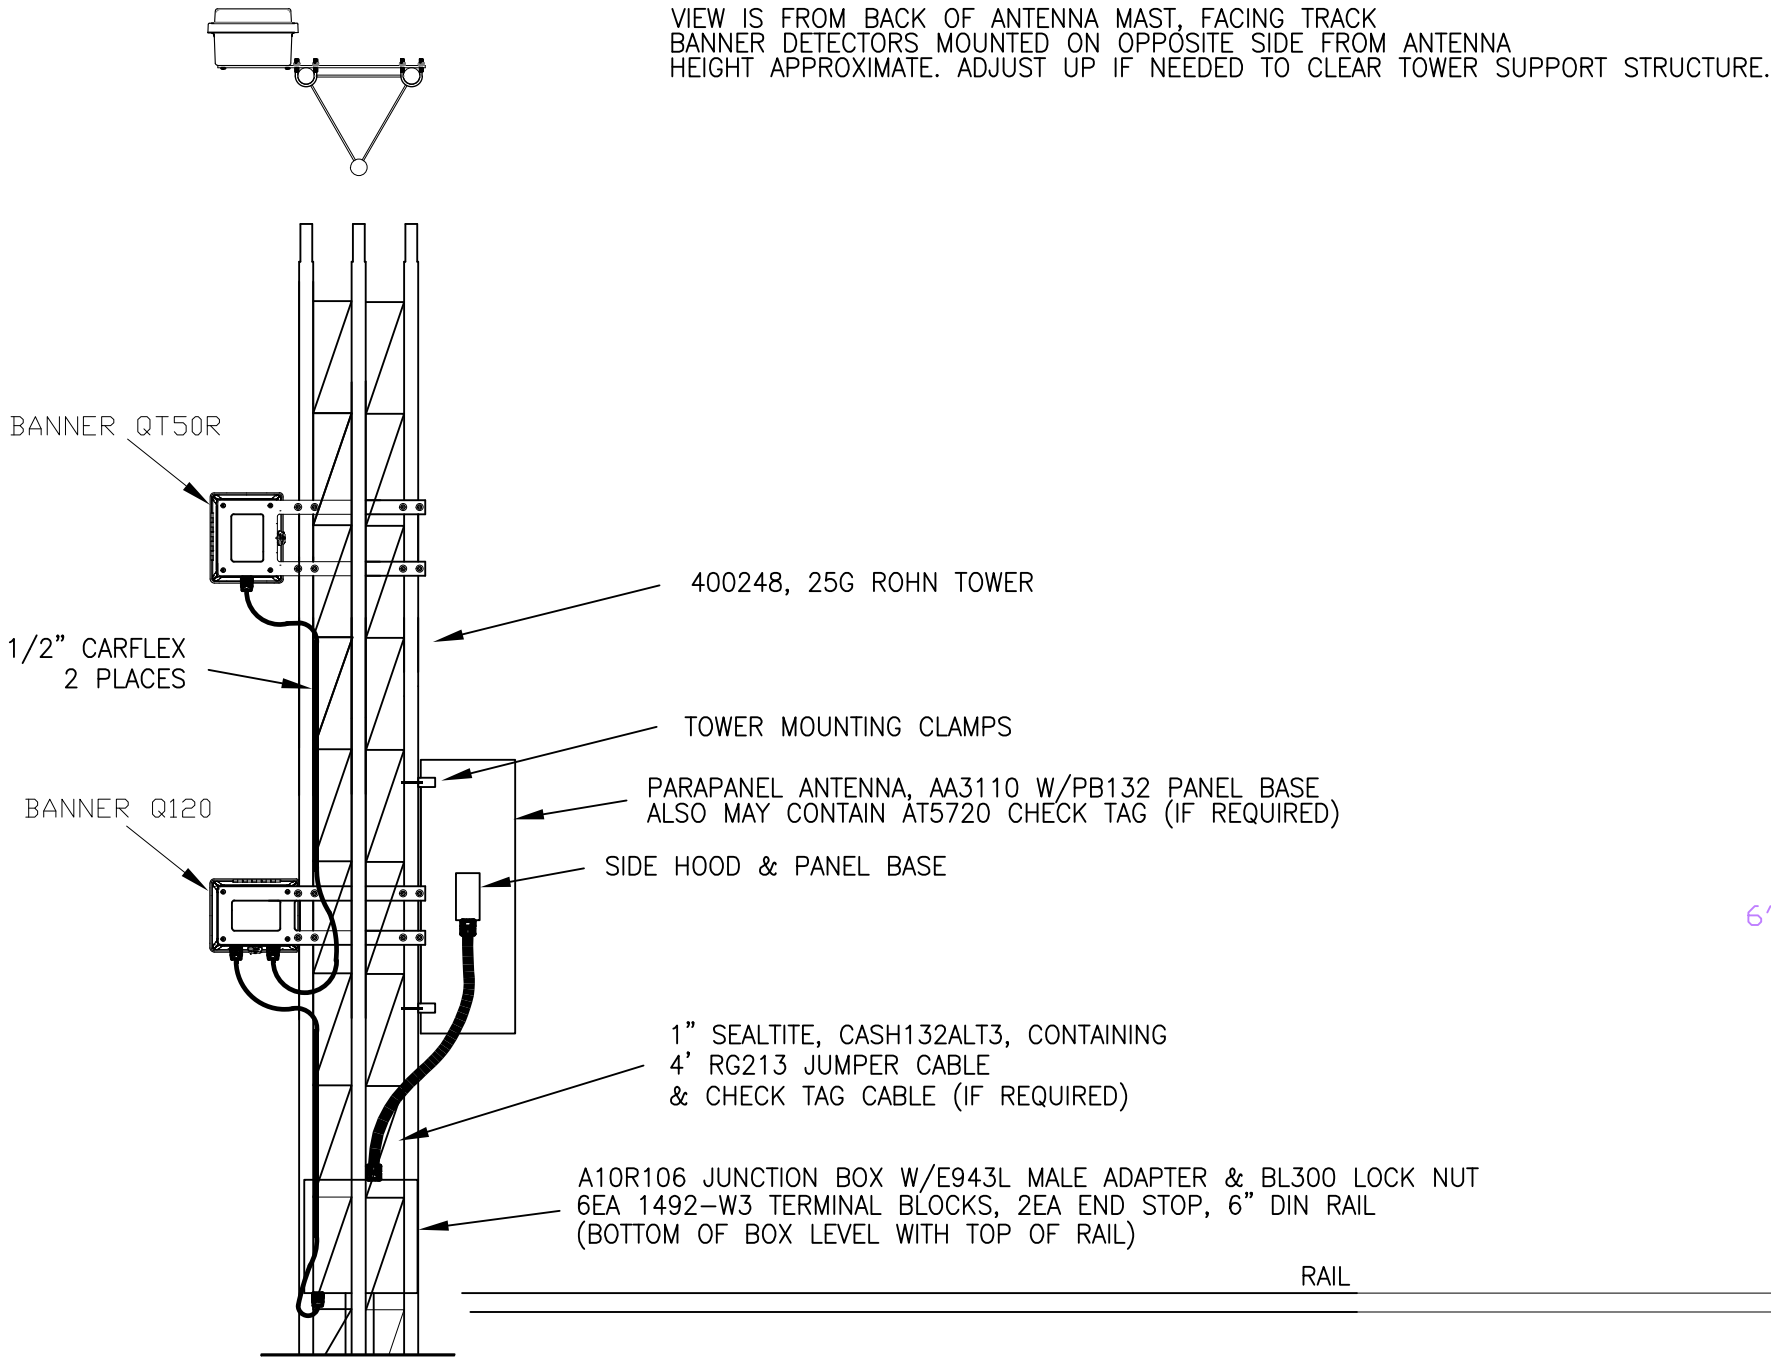

EXPORT REQUIREMENT NOTICE:
THESE COMMODITIES, TECHNOLOGY OR SOFTWARE WERE EXPORTED FROM THE UNITED STATES IN ACCORDANCE WITH THE EXPORT ADMINISTRATION REGULATIONS. DIVERSION CONTRARY TO U.S. LAW IS PROHIBITED. THE COMMODITIES MAY NOT BE RESOLD, TRANSFERRED, TRANSSHIPPED OR REEXPORTED WITHOUT PRIOR AUTHORIZATION BY THE U.S. GOVERNMENT.

DRAWN DDC	DATE 03.21.2018
ENGINEER	DATE
APPROVED	DATE

 Comet Electronics		2405 Nicholson Ave. Kansas City, MO 64120			
DWG NAME					
BANNER PRESENCE DETECTOR MOUNTING DETAIL					
<u>COMET Proprietary</u> USE OF THIS DOCUMENT AND INFORMATION IS ONLY GRANTED UNDER CONSIDERATION OF OR USE UNDER CONTRACTUAL AGREEMENT. DOCUMENT IS PROPERTY OF COMET AND MUST BE RETURNED/DESTROYED ON REQUEST.		DWG NO. 70-0193-03		PARTS SHOWN	REV A
		DIMENSIONS: IN [mm]	SCALE N.T.S.	SHEET 1	OF 1