


REV	DESCRIPTION	DATE	APPROVAL
A	GENERIC CONNECTION LABELS	09.09.21	DDC
B	UPDATED BRANDING & ADDITIONAL LABELS (PDN: 101-24)	08.08.25	----

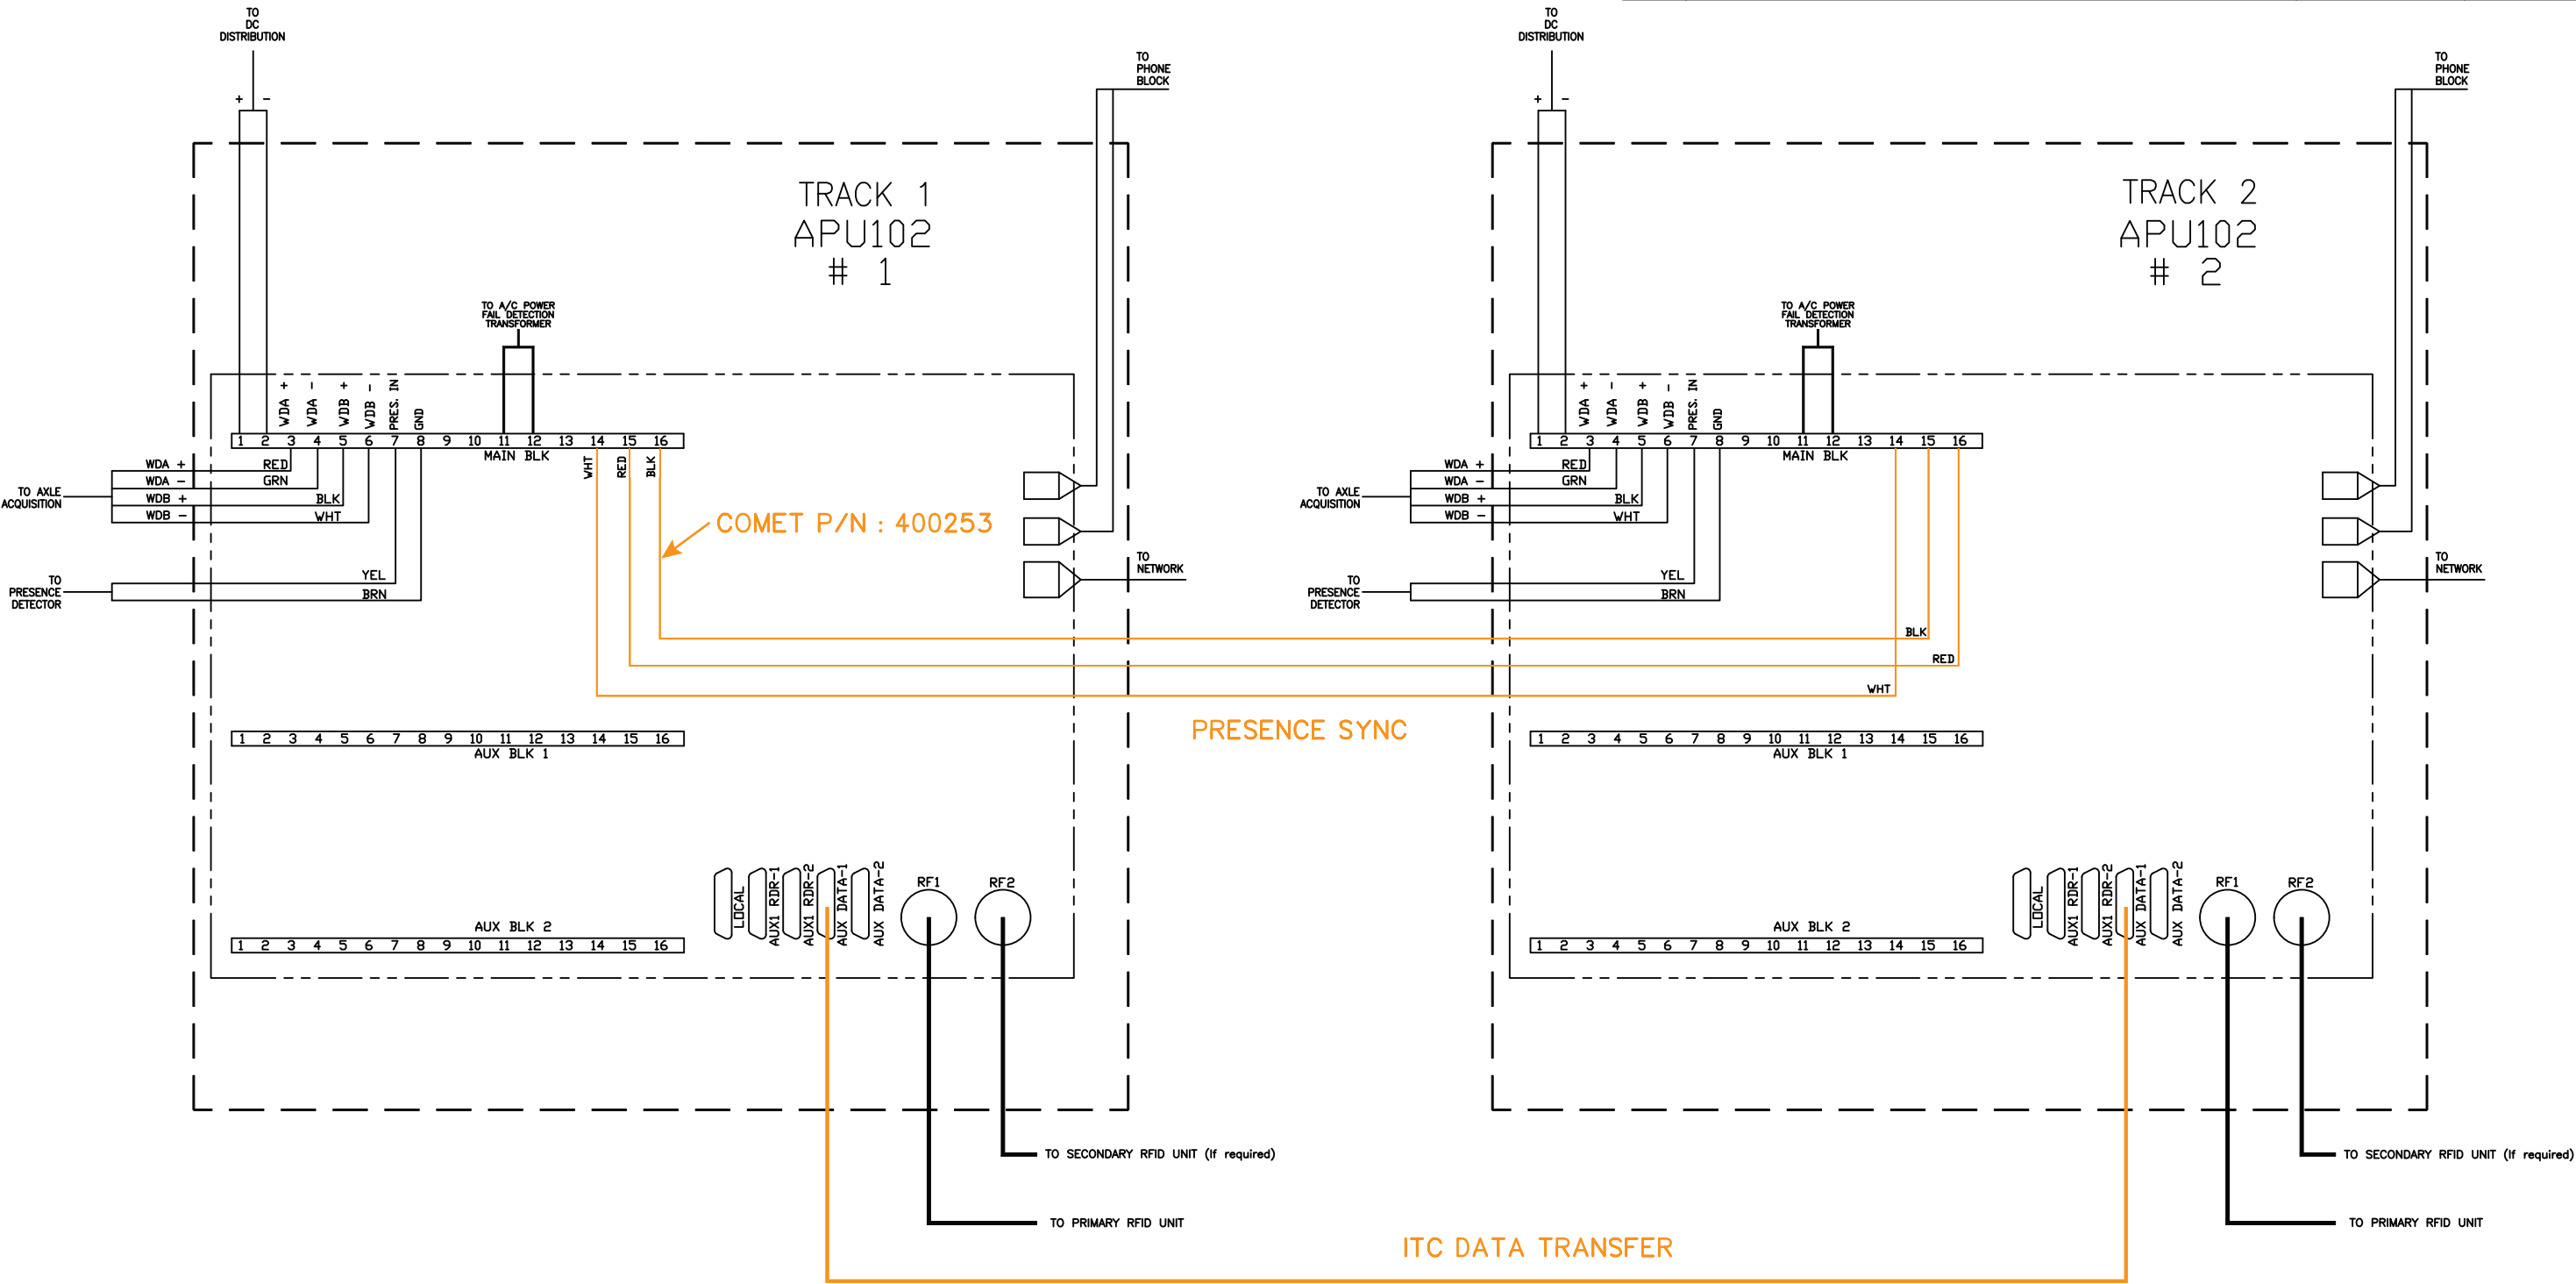

INTERCONNECT CABLES FOR DOUBLE TRACK SITES	
#1 - APU102 #1 MAIN TERMINAL BLOCK TO APU102 #2 MAIN TERMINAL BLOCK	
PIN 14 (GND)	TO PIN 14 (GND)
PIN 15 (DBL IN)	TO PIN 16 (DBL OUT)
PIN 16 (DBL OUT)	TO PIN 15 (DBL IN)
#2 - APU102 #1 AUX DATA-1 TO APU102 #2 AUX DATA-1	
PIN 2 (TX)	TO PIN 3 (RX)
PIN 3 (RX)	TO PIN 2 (TX)
PIN 4 (RTS)	TO PIN 5 (CTS)
PIN 5 (CTS)	TO PIN 4 (RTS)
PIN 6 (DSR)	TO PIN 20 (DTR)
PIN 20 (DTR)	TO PIN 6 (DSR)
PIN 7 (GND)	TO PIN 7 (GND)

		NAME	DATE	TITLE DOUBLE TRACK AEI COMMUNICATIONS
	DRAWN	IAK	05.06.98	
	APPROVED	----	----	
2405 NICHOLSON AVE, KANSAS CITY, MO 64120		DIVISION ELECTRONICS	PART NUMBER ----	
USE OF THIS DOCUMENT AND INFORMATION IS ONLY GRANTED UNDER CONSIDERATION OF OR USE UNDER CONTRACTUAL AGREEMENT. THIS DOCUMENT IS PROPERTY OF COMET INDUSTRIES AND MUST BE RETURNED / DESTROYED ON REQUEST.		SERIES WIRING	DESCRIPTION DOUBLE TRACK INTER-SYSTEM COMMUNICATION WIRING	
		PROJECT ----	DWG NO. 481200	VERSION B
			SCALE NTS	SHEET 1 OF 1