


REV	REVISION DESCRIPTION	DATE	APPROVAL

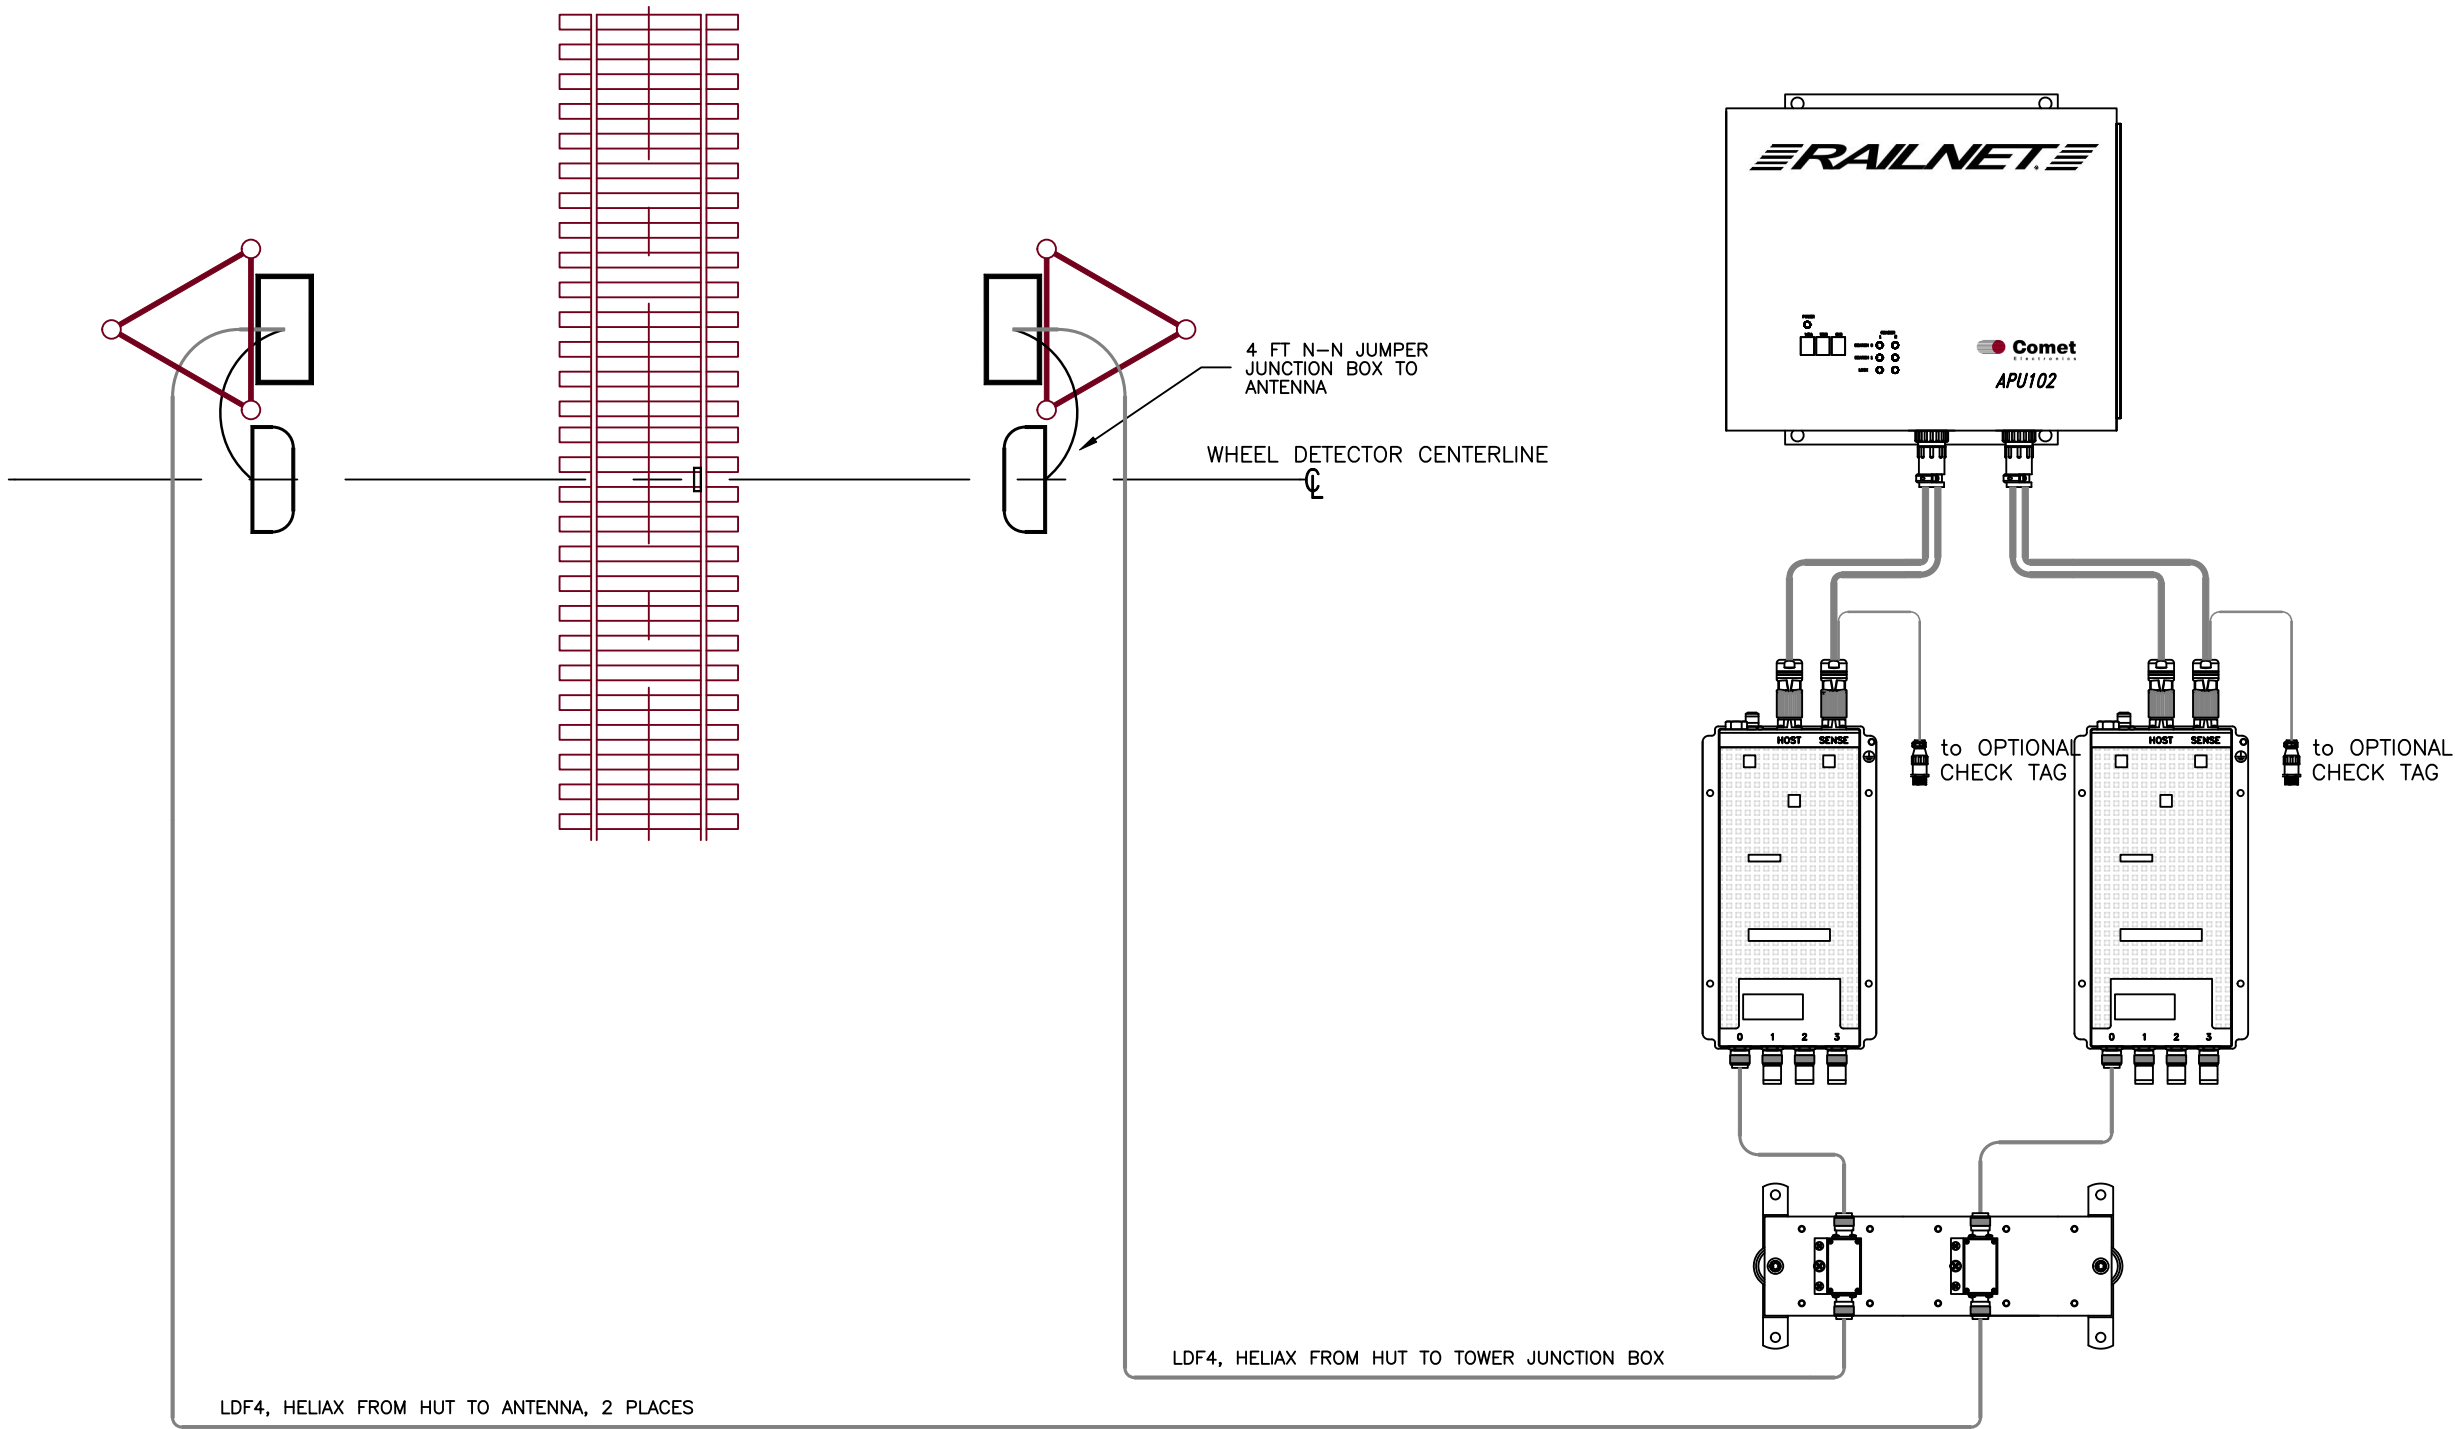

EXPORT REQUIREMENT NOTICE:
THESE COMMODITIES, TECHNOLOGY OR SOFTWARE WERE EXPORTED FROM THE UNITED STATES IN ACCORDANCE WITH THE EXPORT ADMINISTRATION REGULATIONS. DIVERSION CONTRARY TO U.S. LAW IS PROHIBITED. THE COMMODITIES MAY NOT BE RESOLD, TRANSFERRED, TRANSSHIPPED OR REEXPORTED WITHOUT PRIOR AUTHORIZATION BY THE U.S. GOVERNMENT.

DRAWN DDC	DATE 03.09.2020
ENGINEER	DATE
APPROVED	DATE



2405 Nicholson Ave.
Kansas City, MO 64120

DWG NAME MPRX WIRING DETAIL HIGH SPEED, DEDICATED RF	
COMET Proprietary USE OF THIS DOCUMENT AND INFORMATION IS ONLY GRANTED UNDER CONSIDERATION OF OR USE UNDER CONTRACTUAL AGREEMENT. DOCUMENT IS PROPERTY OF COMET AND MUST BE RETURNED/DESTROYED ON REQUEST.	DWG NO. 571-0017-06
DIMENSIONS: IN [mm]	SCALE N.T.S.
PARTS SHOWN	SHEET OF
1	1