


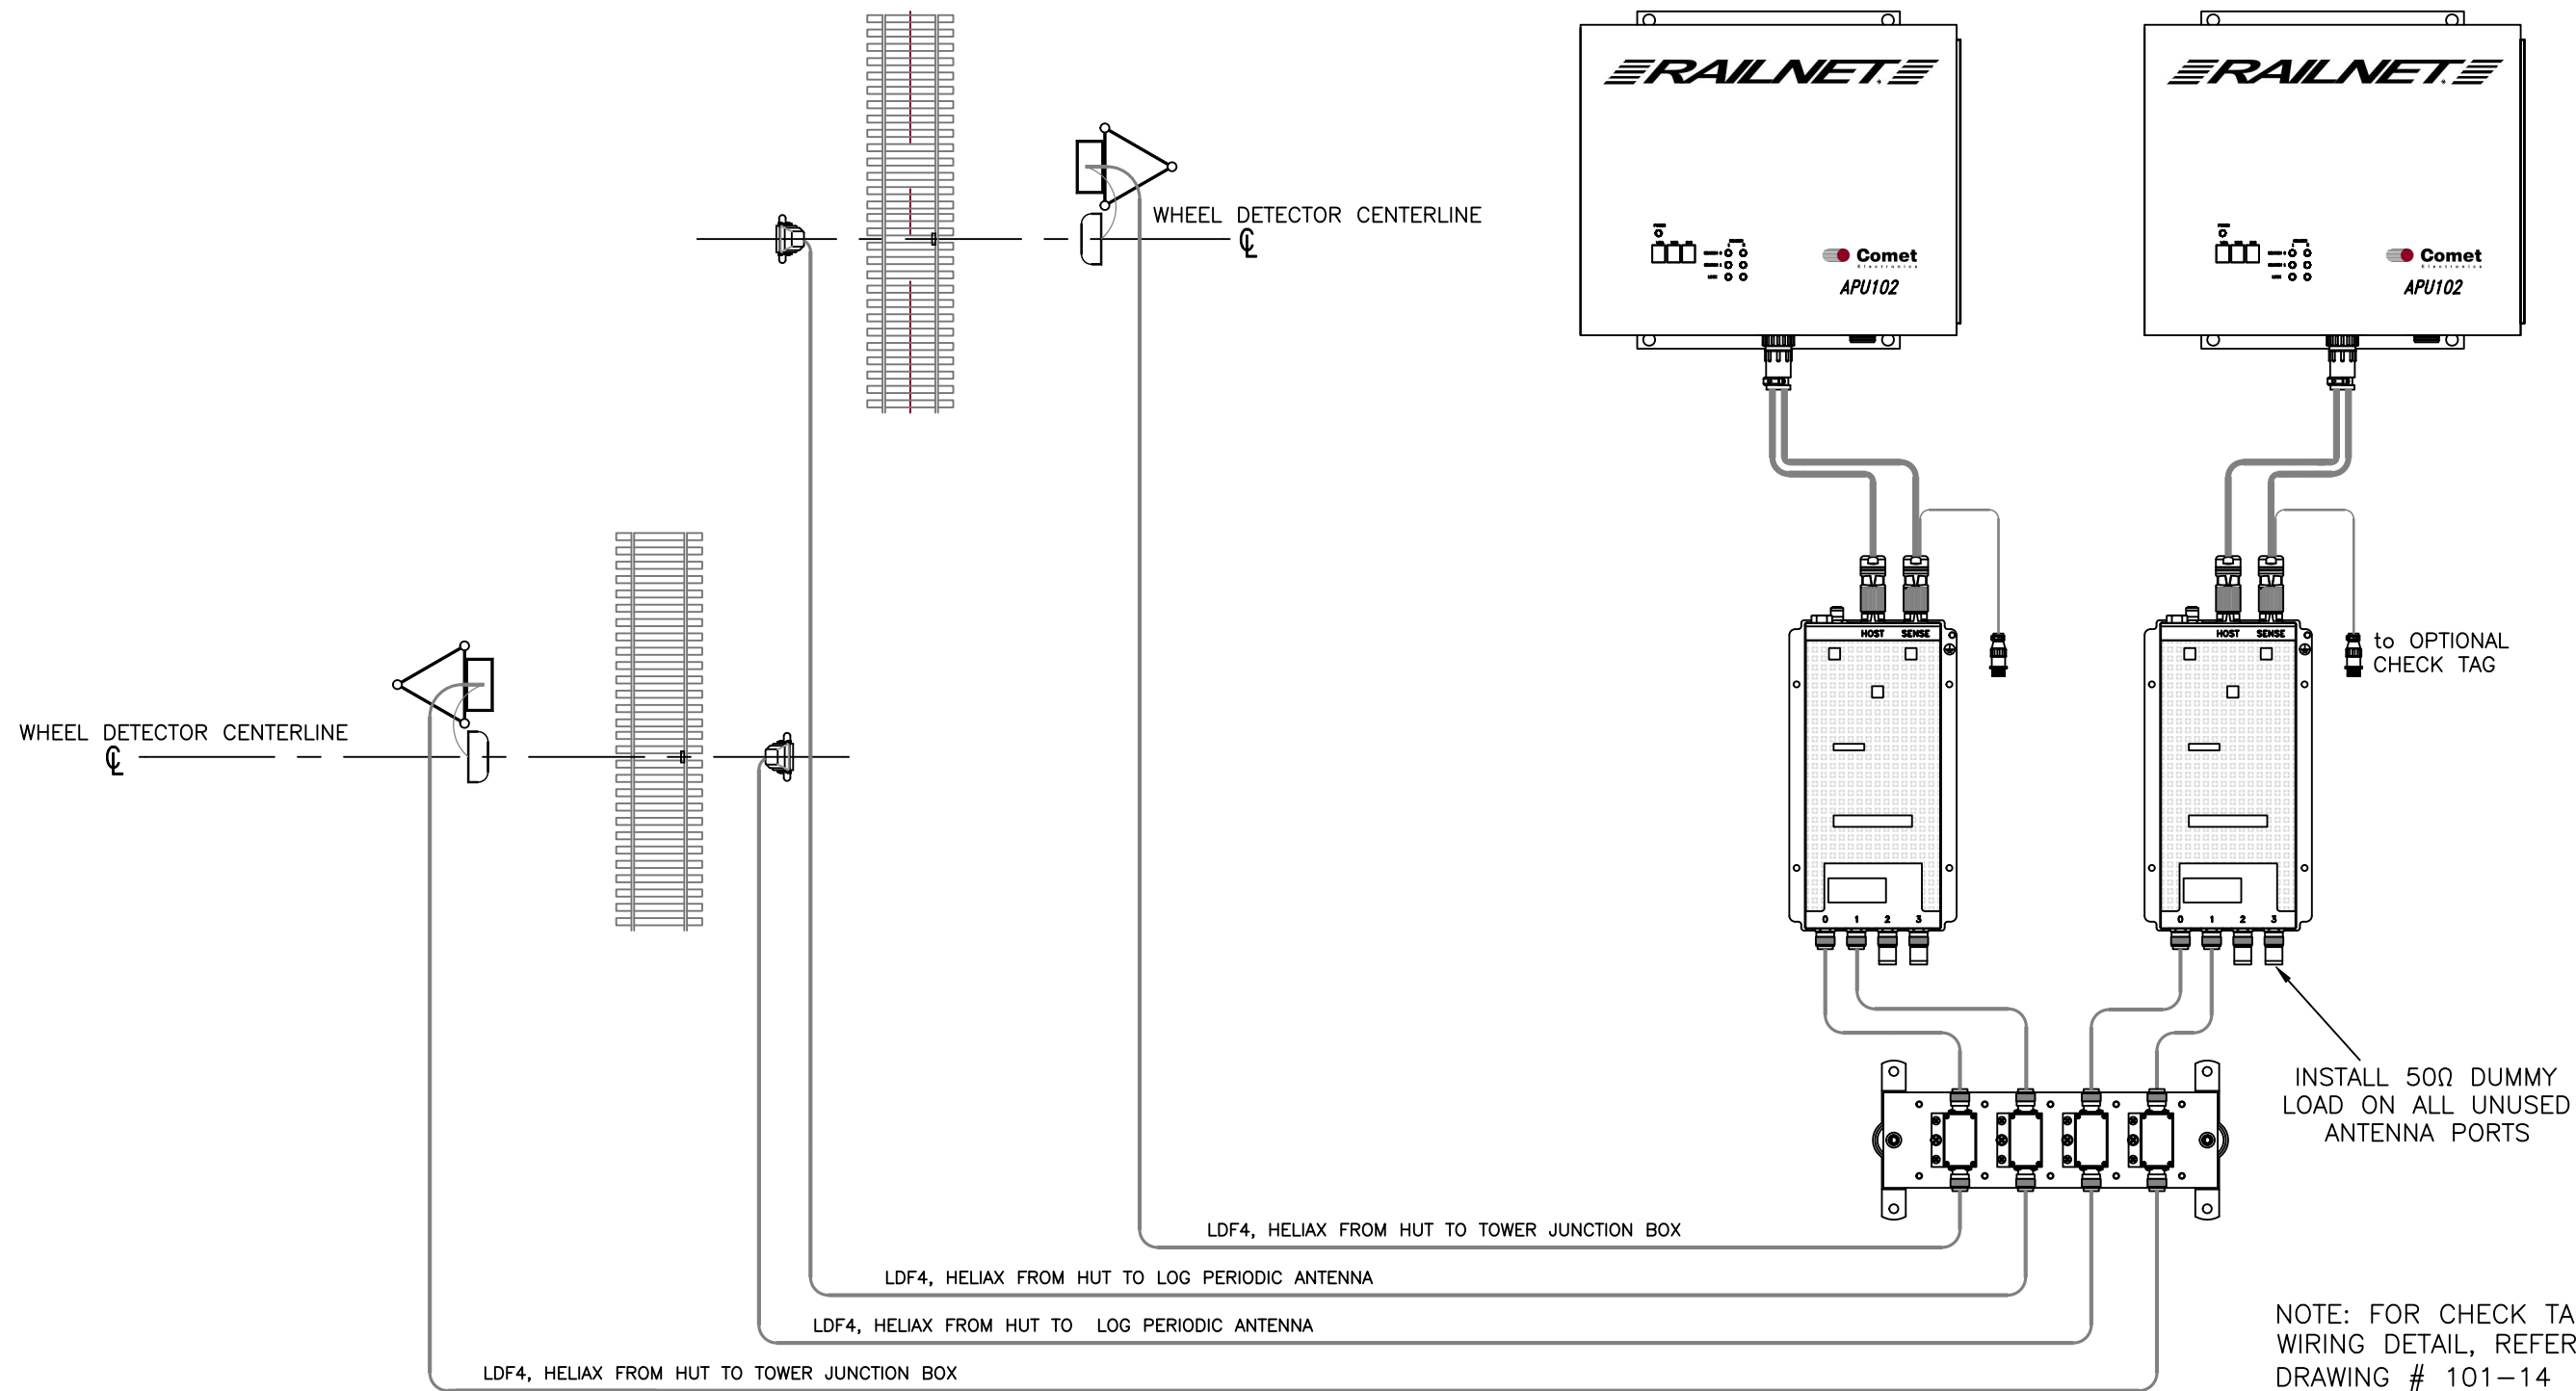

**Comet**
Electronics

2405 Nicholson Ave.
Kansas City, MO 64120

DWG NAME		MPRX WIRING DETAIL			
		DOUBLE TRACK LOW/MEDIUM SPEED RESTRICTED			
COMET Proprietary		DWG NO.	PARTS SHOWN	REV	
USE OF THIS DOCUMENT AND INFORMATION IS ONLY GRANTED UNDER CONSIDERATION OF OR USE UNDER CONTRACTUAL AGREEMENT. DOCUMENT IS PROPERTY OF COMET AND MUST BE RETURNED/DESTROYED ON REQUEST.		571-0017-07		-	
		DIMENSIONS:	SCALE	SHEET	OF
		IN [mm]	N.T.S.	1	1

EXPORT REQUIREMENT NOTICE:
THESE COMMODITIES, TECHNOLOGY OR SOFTWARE WERE EXPORTED FROM THE UNITED STATES IN ACCORDANCE WITH THE EXPORT ADMINISTRATION REGULATIONS. DIVERSION CONTRARY TO U.S. LAW IS PROHIBITED. THE COMMODITIES MAY NOT BE RESOLD, TRANSFERRED, TRANSSHIPPED OR REEXPORTED WITHOUT PRIOR AUTHORIZATION BY THE U.S. GOVERNMENT.

DRAWN	DATE
DDC	09.08.2021
ENGINEER	DATE
APPROVED	DATE