


REV	REVISION DESCRIPTION	DATE	APPROVAL

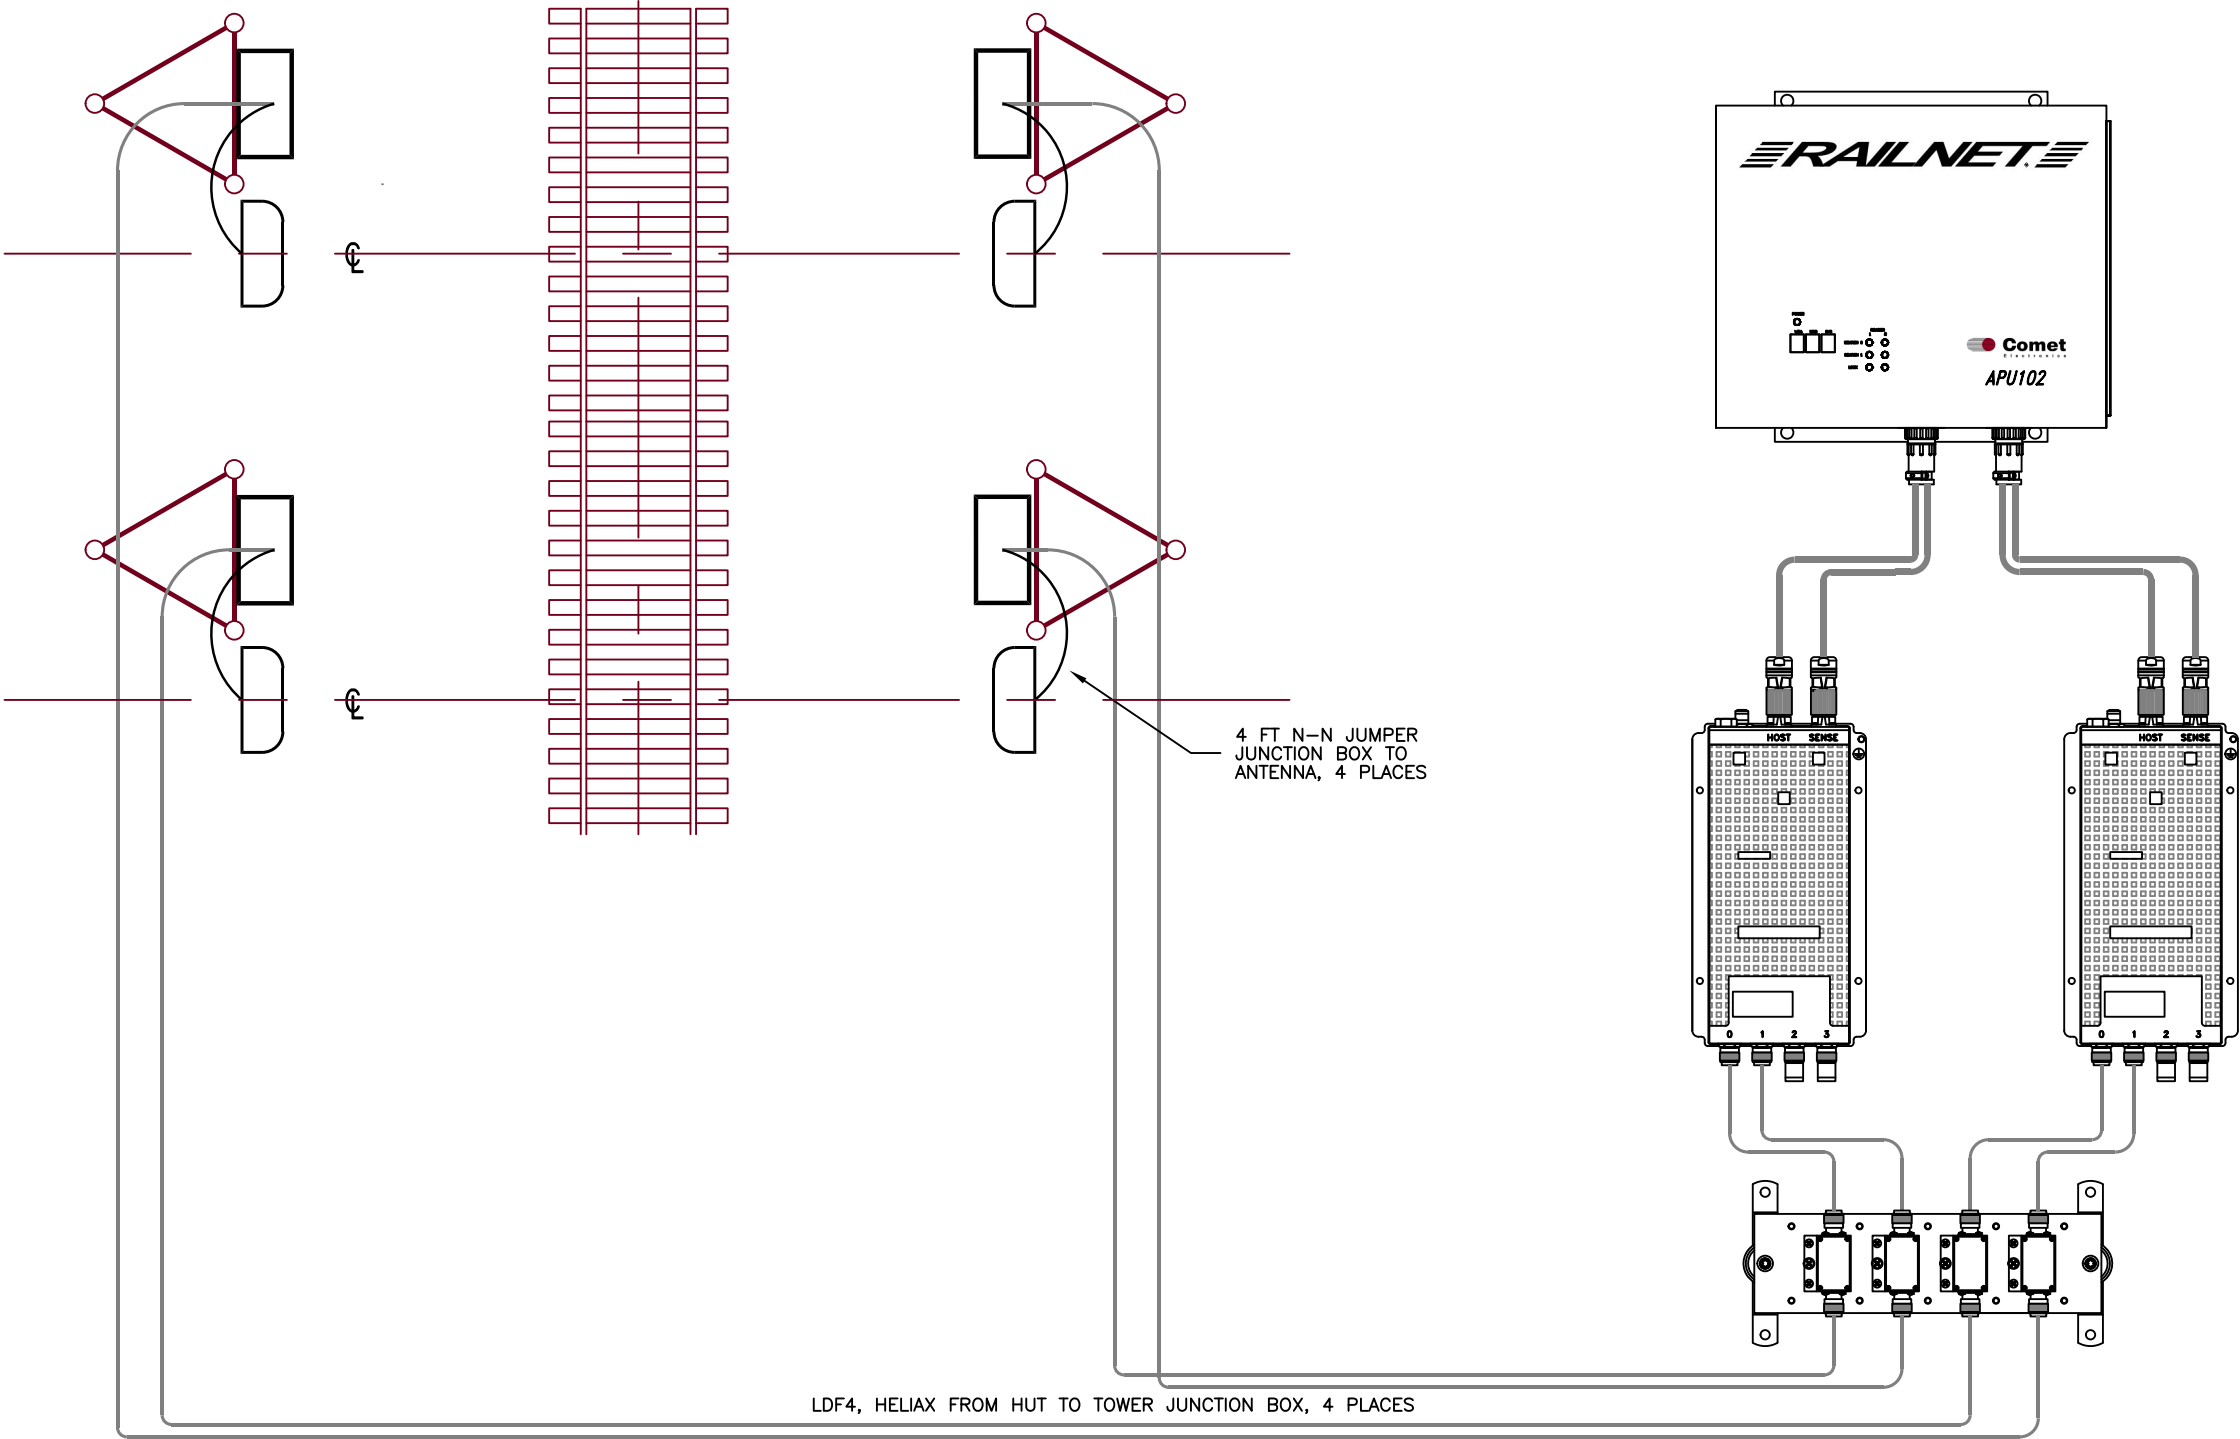

2405 Nicholson Ave.
Kansas City, MO 64120

DWG NAME			
RF WIRING DIAGRAM			
SINGLE TRACK ULTRA HIGH SPEED			
COMET Proprietary		DWG NO.	PARTS SHOWN
USE OF THIS DOCUMENT AND INFORMATION IS ONLY GRANTED UNDER CONSIDERATION OF OR USE UNDER CONTRACTUAL AGREEMENT. DOCUMENT IS PROPERTY OF COMET AND MUST BE RETURNED/DESTROYED ON REQUEST.		571-0017-01	REV -
DIMENSIONS:	SCALE	SHEET	OF
IN [mm]	N.T.S.	1	1

EXPORT REQUIREMENT NOTICE:
THESE COMMODITIES, TECHNOLOGY OR SOFTWARE WERE EXPORTED FROM THE UNITED STATES IN ACCORDANCE WITH THE EXPORT ADMINISTRATION REGULATIONS. DIVERSION CONTRARY TO U.S. LAW IS PROHIBITED. THE COMMODITIES MAY NOT BE RESOLD, TRANSFERRED, TRANSSHIPPED OR REEXPORTED WITHOUT PRIOR AUTHORIZATION BY THE U.S. GOVERNMENT.

DRAWN	DATE
DDC	01.10.2019
ENGINEER	DATE
DDC	12.04.2018
APPROVED	DATE
SWS	01.25.2019